

TOTAL AREA:- 4327.27 Sq.Ft.

**AYURVEDA AUSHADHI UTPADAN KENDRA
GROUND FLOOR PLAN
(281.61 SQ. M.)**

NOTE:-

LEGEND:

REVISIONS:-


SUFFIX	DATE	INITIALS	REVISION DETAILS
A.			
B.			
C.			
D.			

AYURVEDA AUSHADHI UTPADAN KENDRA
AT
Ratnanagar municipality-1 Chitwan (Nepal.)


SERVICE CONSULTANT:
ACTIVE ELECTROMECHANICAL
Engineering Associates Pvt. Ltd.

SHEET TITLE:
CIVIL LAYOUT PLAN (G.F)

DESIGNED BY:-	DRAWN BY:-	APPROVED BY:-	SHEET NO:-
ROBHAN	INDRA		HVAC 01
DATE:-	13 Oct, 2023		
SCALE:-	NTS		
PROJECT NO:-			

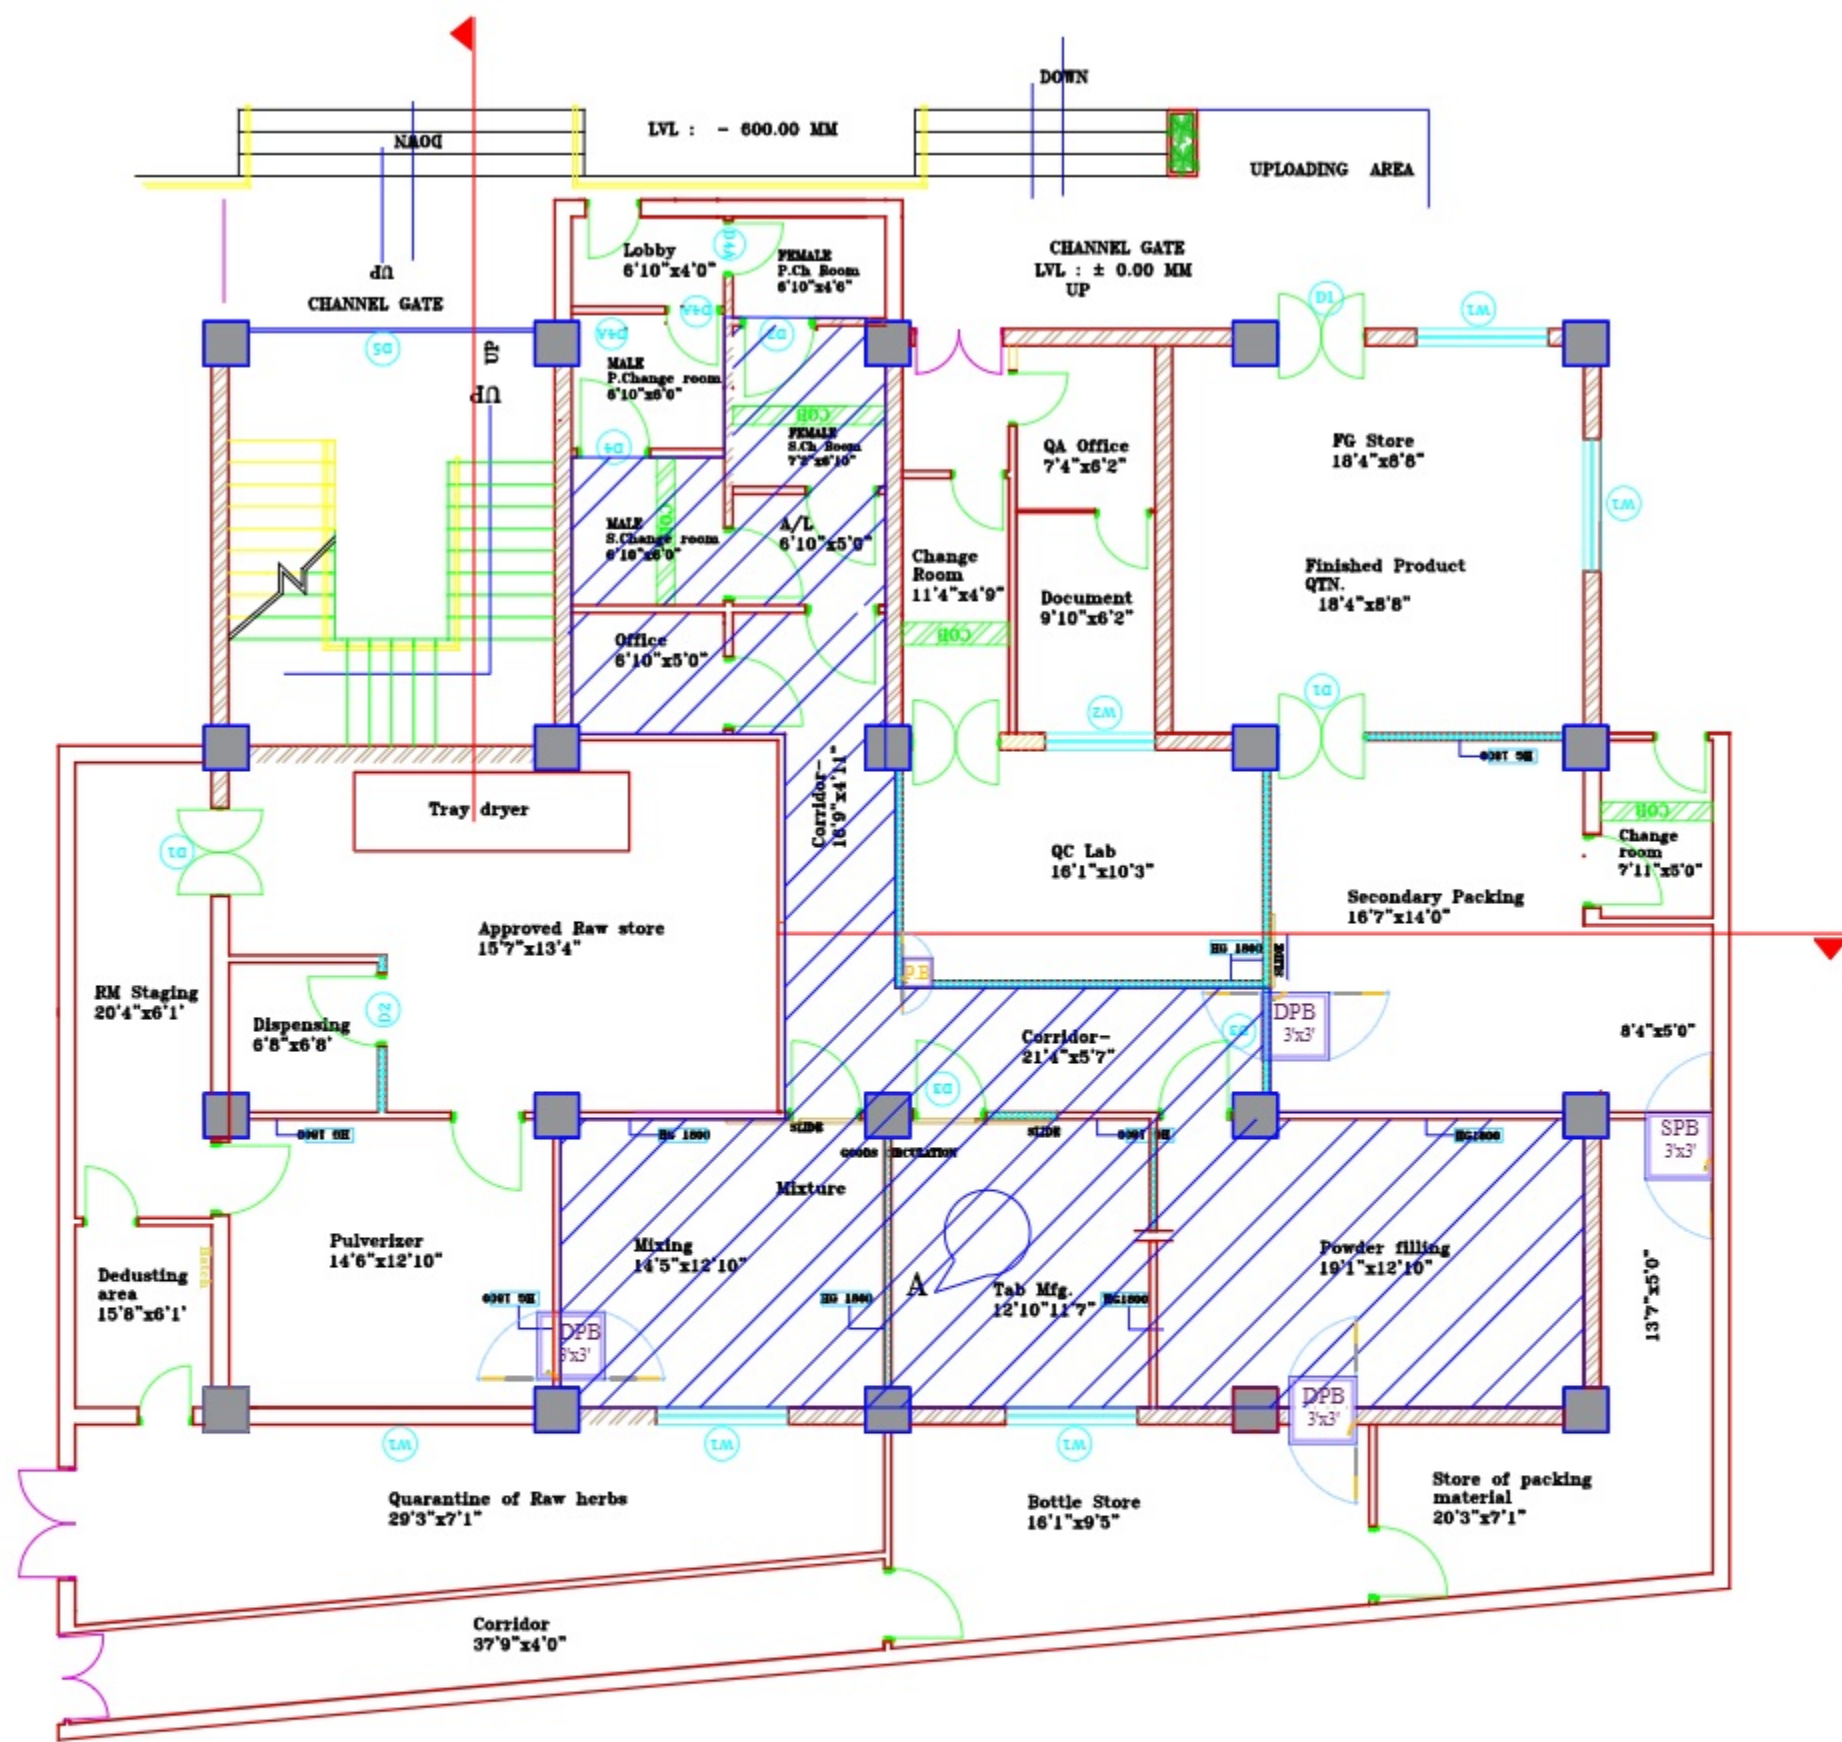

TOTAL AREA:- 4327.27 Sq.Ft.
 GRAY AREA :- 987.20 Sq.Ft.
 BLACK AREA:- 3340.07 Sq. Ft.

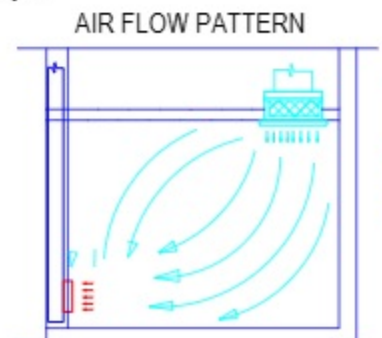

**AYURVEDA AUSHADHI UTPADAN KENDRA
 GROUND FLOOR PLAN
 (281.61 SQ. M.)**

NOTE:-

LEGEND:

REVISIONS:-

SUFFIX	DATE	INITIALS	REVISION DETAILS
A.			
B.			
C.			
D.			

AYURVEDA AUSHADHI UTPADAN KENDRA
 AT
 Ratnanagar municipality-1 Chitwan (Nepal.)


SERVICE CONSULTANT:



SHEET TITLE:
 AHU-SEGREGATION PLAN (G.F)

DESIGNED BY:-	DRAWN BY:-	APPROVED BY:-	SHEET NO:-
ROBHAN	INDRA		HVAC 02

DATE:- 13 Oct, 2023
 SCALE:- NTS
 PROJECT NO:-

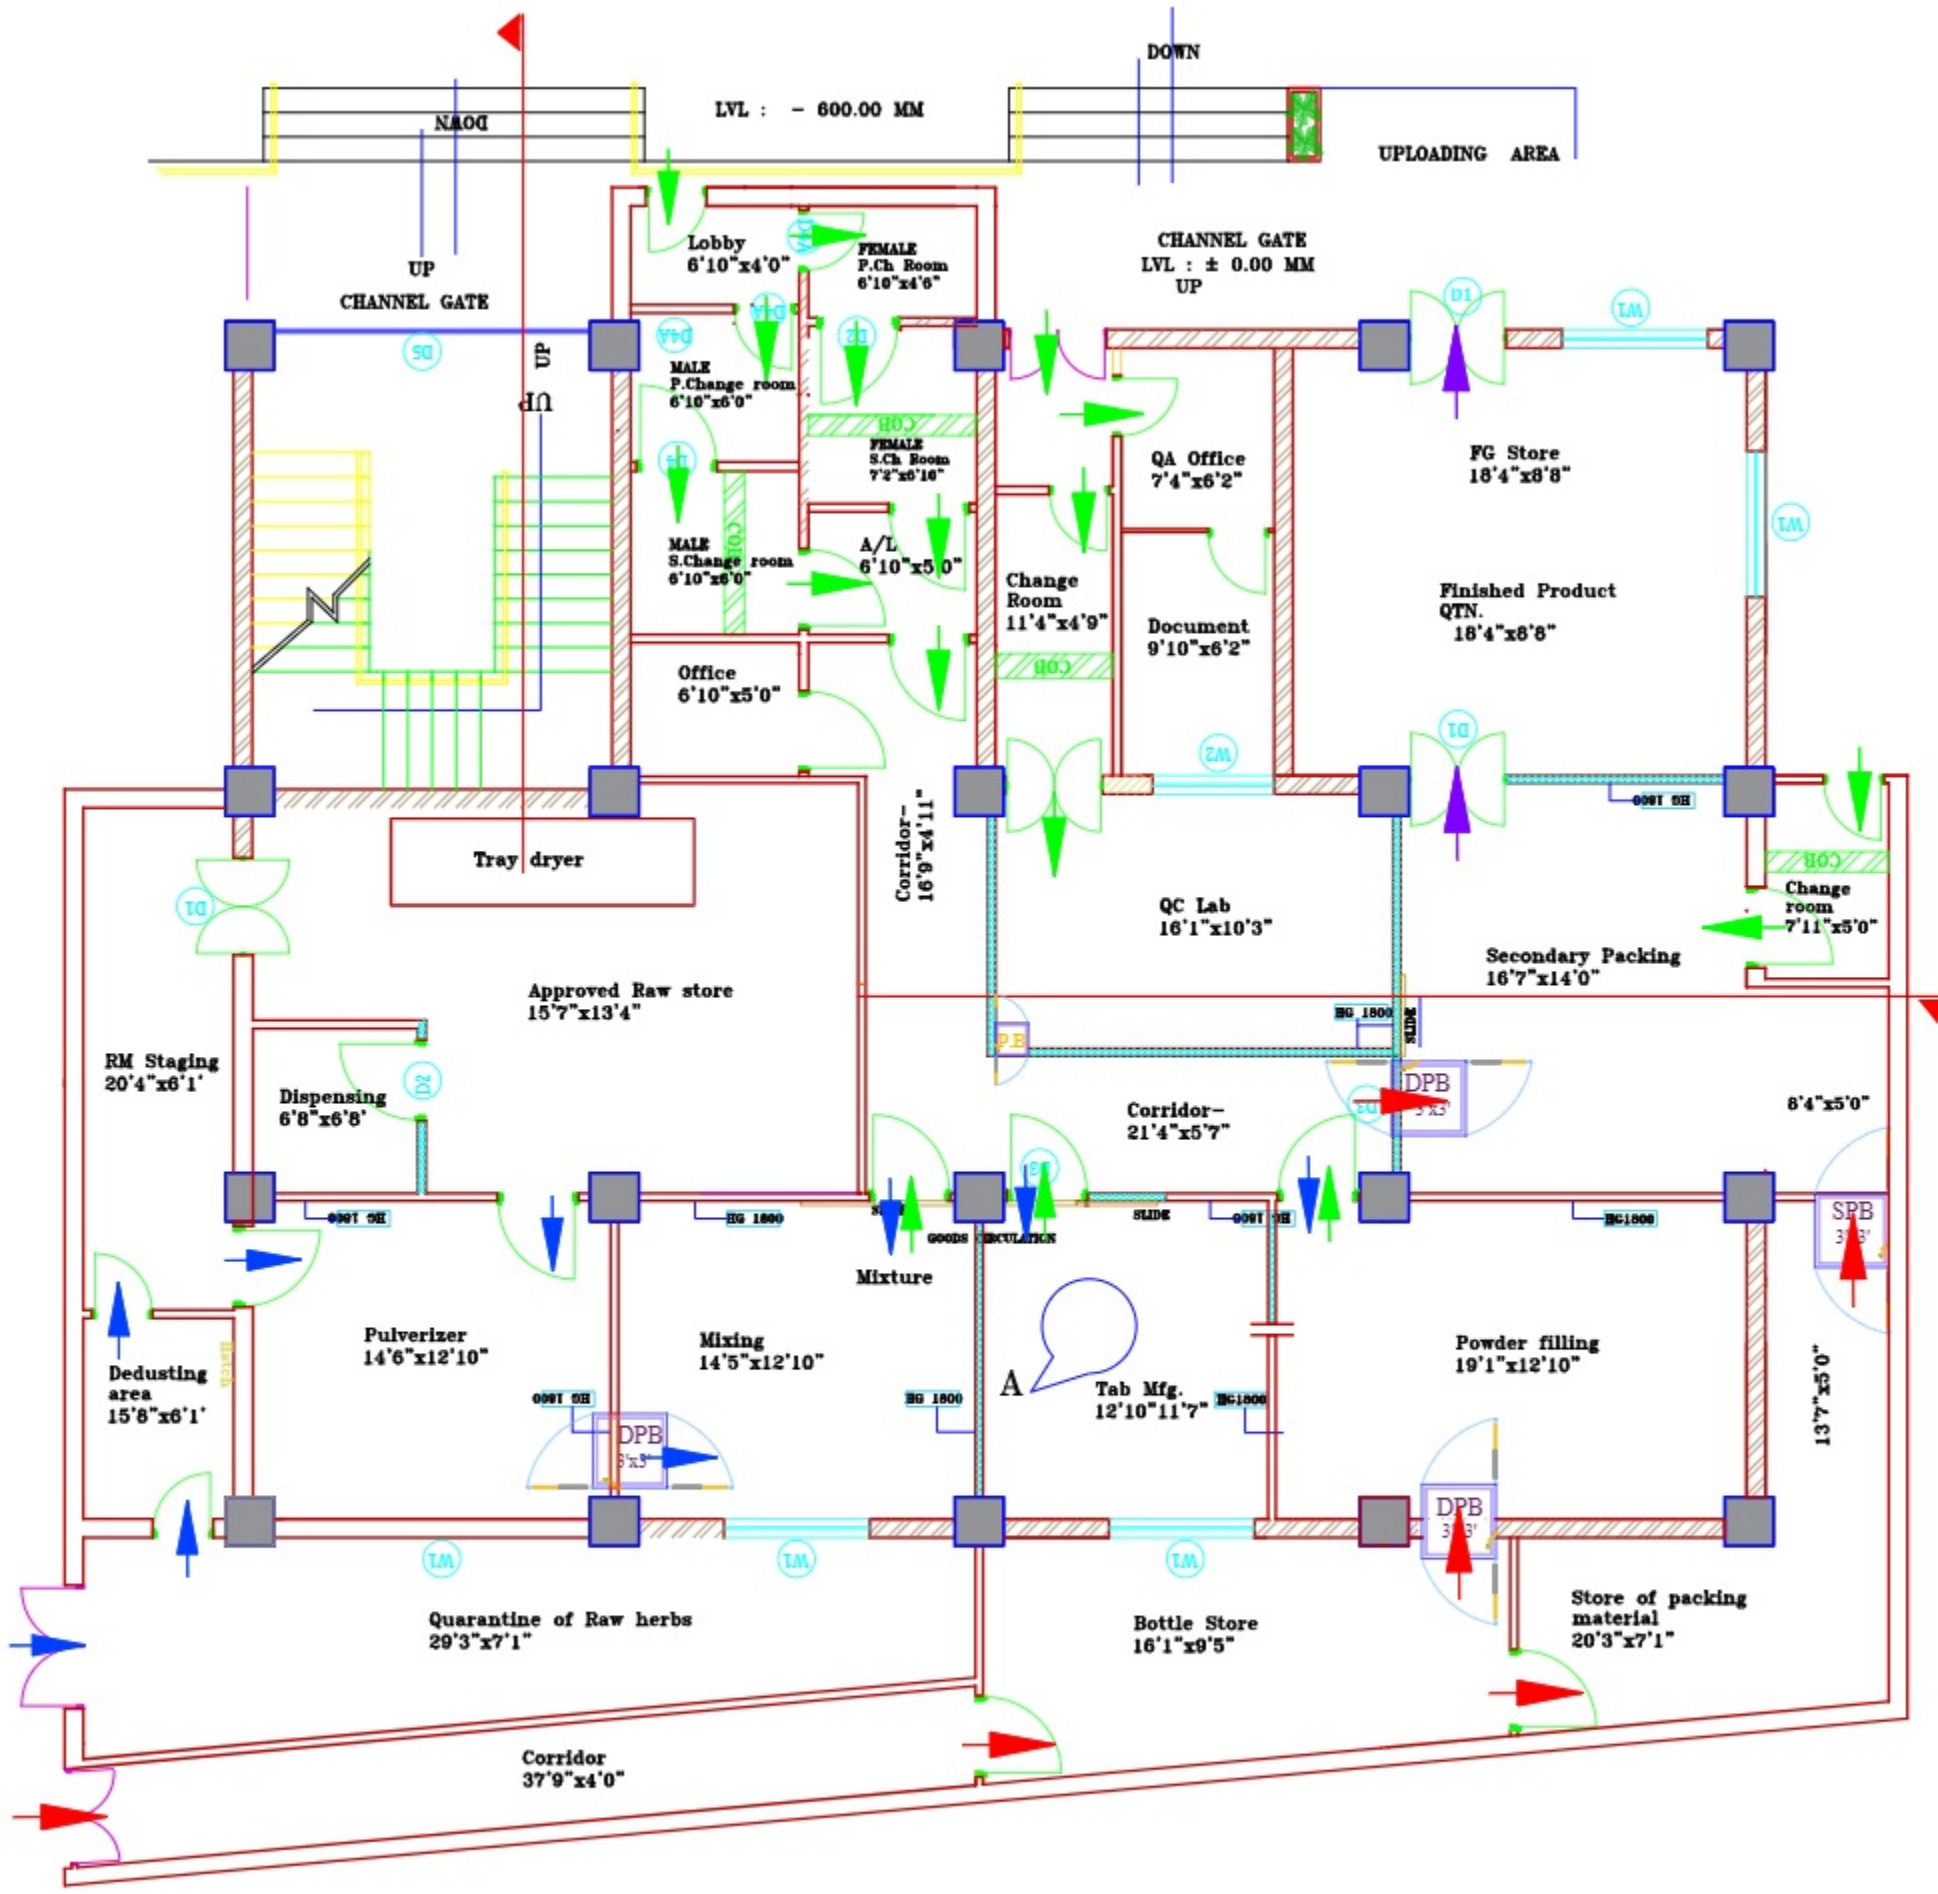

AYURVEDA AUSHADHI UTPADAN KENDRA
GROUND FLOOR PLAN
(281.61 SQ. M.)

Legend

Men flow	
Material flow	
Finished product	
Packing material	

NOTE:-

LEGEND:

REVISIONS:-


SUFFIX	DATE	INITIALS	REVISION DETAILS
A.			
B.			
C.			
D.			

AYURVEDA AUSHADHI UTPADAN KENDRA
AT
Ratanagar municipality-1 Chitwan (Nepal.)

SERVICE CONSULTANT:
ACTIVE ELECTROMECHANICAL
Engineering Associates Pvt. Ltd.
(Nepal)

SHEET TITLE:
FLOW LAYOUT PLAN (G.F.)

DESIGNED BY:-	DRAWN BY:-	APPROVED BY:-	SHEET NO:-
ROBHAN	INDRA		HVAC 03
DATE:-	13 Oct, 2023		
SCALE:-	NTS		
PROJECT NO:-			

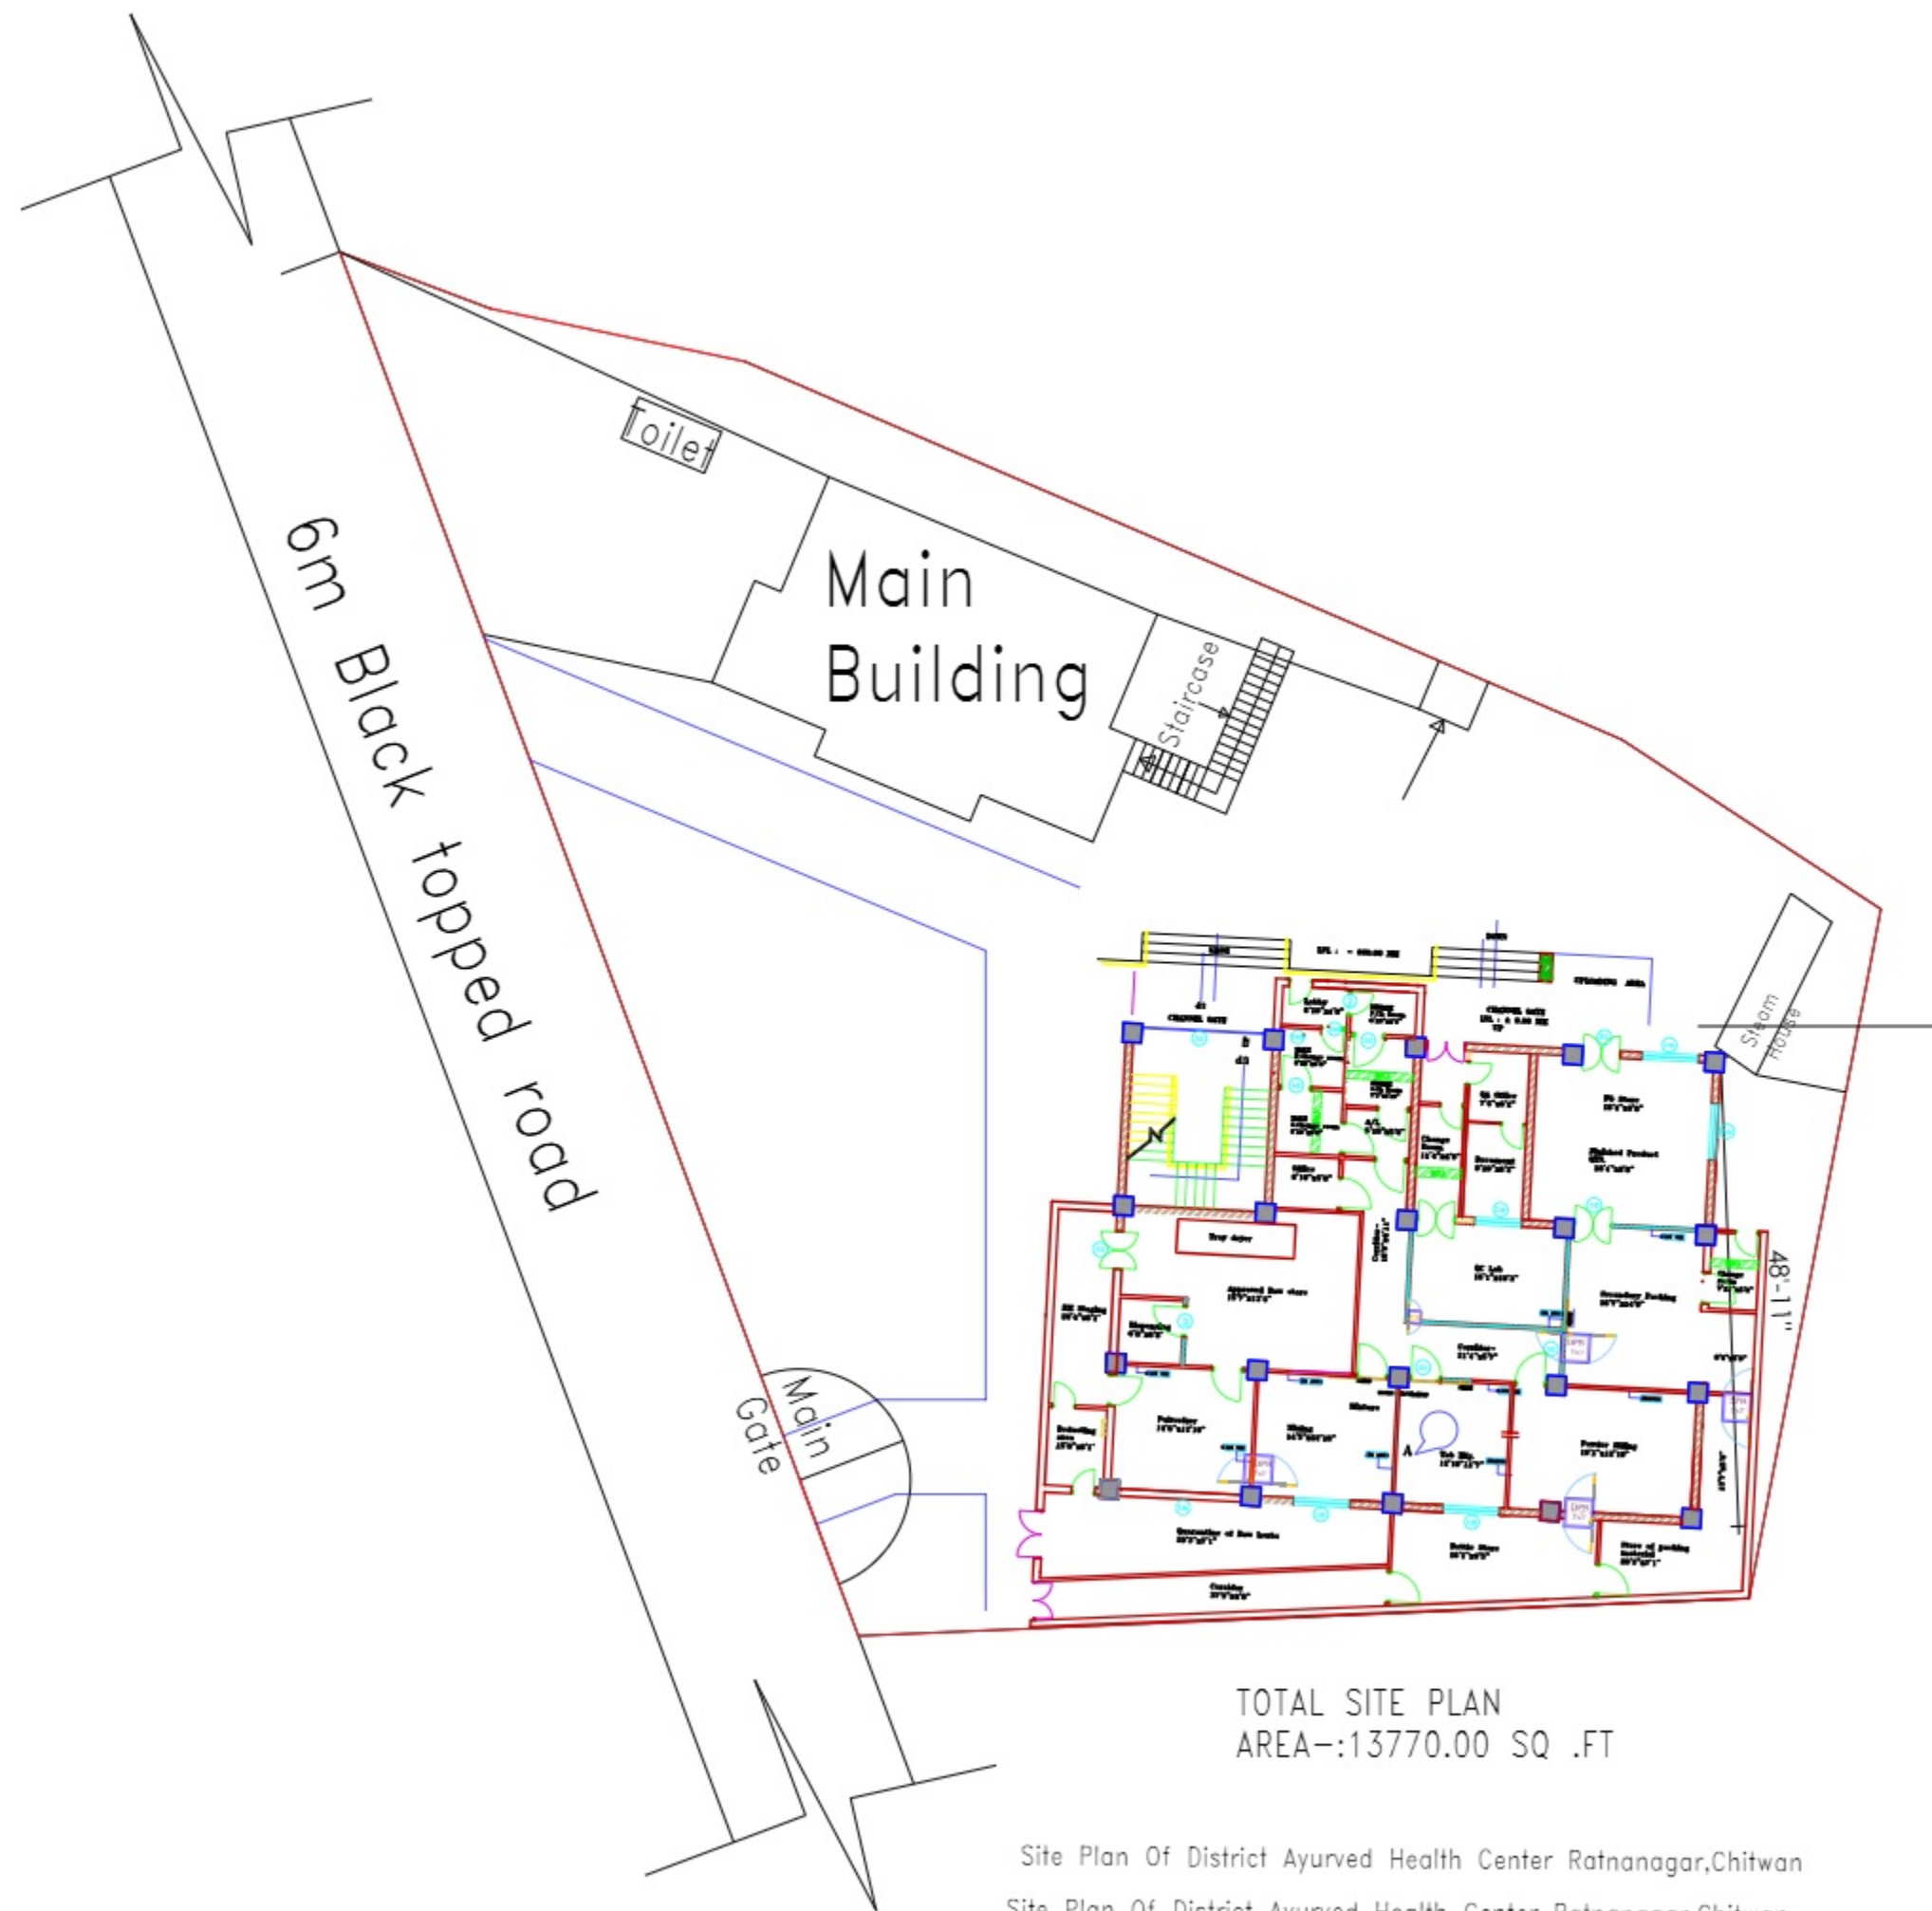

TOTAL SITE PLAN
AREA:-13770.00 SQ .FT

Site Plan Of District Ayurved Health Center Ratnanagar,Chitwan
Site Plan Of District Ayurved Health Center Ratnanagar,Chitwan

NOTE:-

LEGEND:

REVISIONS:-

SUFFIX	DATE	INITIALS	REVISION DETAILS
A.			
B.			
C.			
D.			

AYURVEDA AUSADHI UTPADAN KENDRA
AT
Ratnanagar municipality-1 Chitwan (Nepal.)

SERVICE CONSULTANT:



SHEET TITLE:

SITE PLAN (G.F)

DESIGNED BY:-	DRAWN BY:-	APPROVED BY:-	SHEET NO:-
ROBHAN	INDRA		HVAC 04
DATE:-	13 Oct, 2023		
SCALE:-	NTS		
PROJECT NO:-			